

**ERIKSSON
ENGINEERING
ASSOCIATES, LTD.**

229 E WISCONSIN AVE, STE. 1102
MILWAUKEE, WISCONSIN 53202
PHONE: (414) 224-5100
FAX: (414) 224-5101
EMAIL: INFO@EEA-LTD.COM

RED HAWK APARTMENTS
N PARKVIEW DRIVE & BLANCHE DRIVE
MILTON, WI 53563

Reserved for Seal:





No.	Date	Description
	08.01.19	Owner Review
	08.09.19	Progress Set
	09.10.19	Coordination Set
	09.16.19	Issued for Permit Set
	10.04.19	Reissued for Permit Set
	10.15.19	Issued for Plan Commission

© ERIKSSON ENGINEERING ASSOCIATES, LTD., 2019
THIS PLAN & DESIGN ARE THE PROPERTY OF ERIKSSON ENGINEERING ASSOCIATES, LTD.
NO REPRODUCTION OR USE OF ANY PART OF THIS PLAN IS PERMITTED WITHOUT THE WRITTEN
CONSENT OF ERIKSSON ENGINEERING ASSOCIATES, LTD.

Design By: TOB Approved By: TOB Date: 10.15.19

Sheet Title:
**SANITARY SEWER
EXTENSION PLAN
AND PROFILE**

Sheet No:
C-9.01

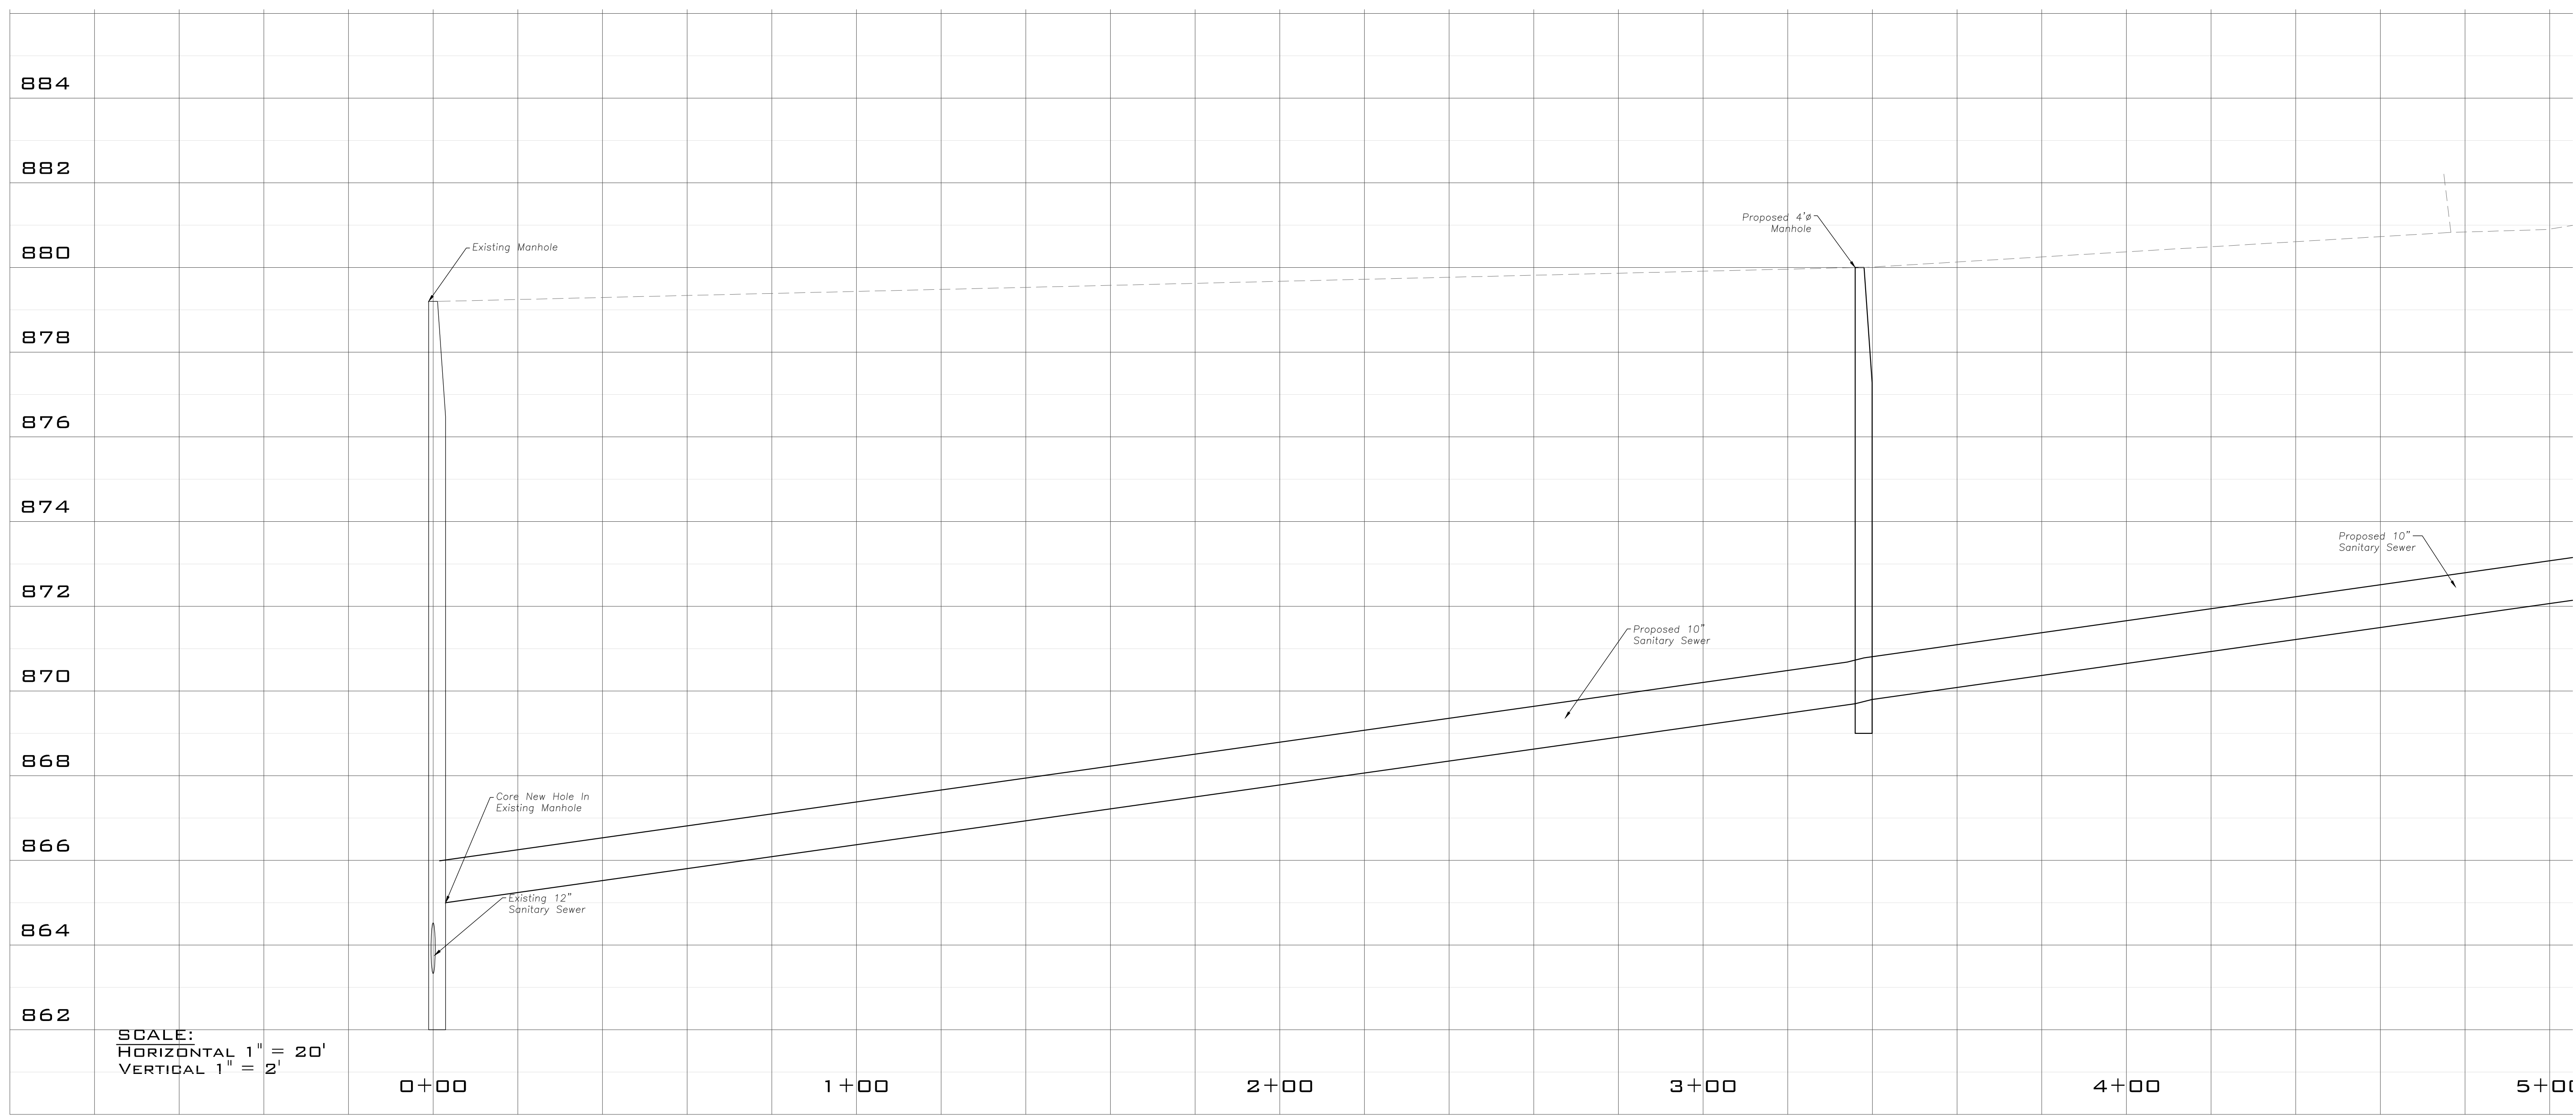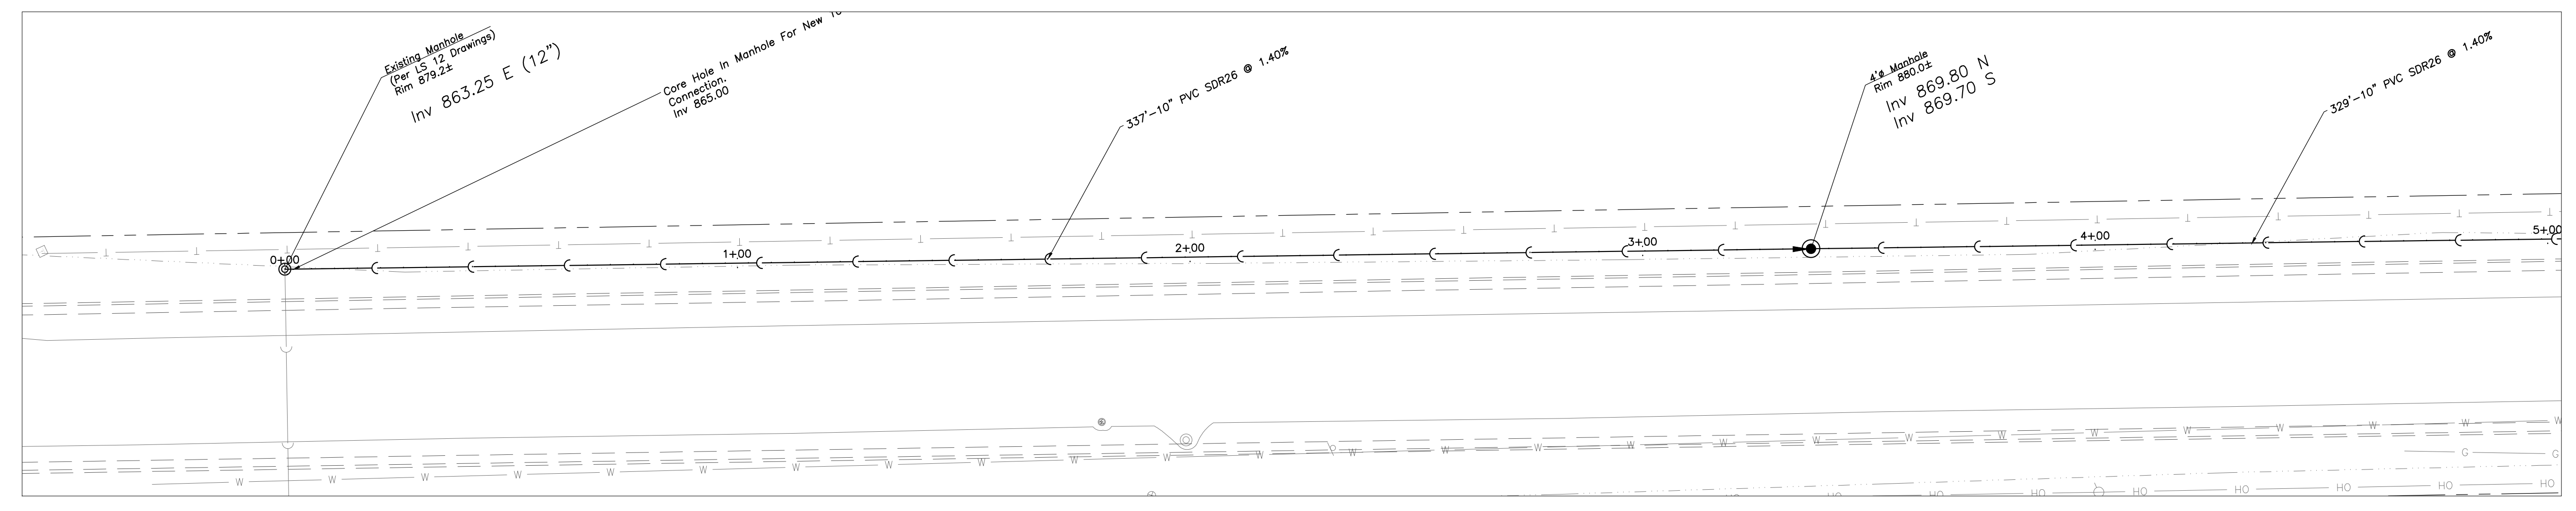

SCALE:
HORIZONTAL 1" = 20'
VERTICAL 1" = 2'

EEA - P:\Jim\Worm Jerabek Witse Architects - Red Hawk Apartments of Milton\Drawings\Red Hawk Site Plan.dwg
Plotted: 10/07/19 @ 3:35pm By: tbrown