

N

**SITE ELECTRICAL PLAN**  
SCALE 1"=50'-0"

**RED HAWK APARTMENTS**

N. Parkview Drive & Blanche Drive  
Milton, WI 53563



ENGINEERS • CONSULTANTS  
DESIGN FIRM LICENSE NO. 184.000894  
2623 EAST PERSHING ROAD DECATUR, IL 62524-2910 217-428-0973 FAX 217-428-8934

**WORN JERABEK WILTSE ARCHITECTS, P.C.**

401 West Superior St, Suite 400  
Chicago, IL 60654  
PH: 312.642.5587 FAX: 312.642.4189 www.wjwarchitecture.com

NO.	ISSUED FOR:	DATE
1	100% DESIGN DEVELOPMENT	8/12/19
3	ISSUED FOR PERMIT	9/09/19



**FOR BID/PERMIT**

ALL REPORTS, PLANS, SPECIFICATIONS, COMPUTER FILES, FIELD DATA, NOTES AND OTHER DOCUMENTS, INCLUDING THOSE IN ELECTRONIC FORM, PREPARED BY BWC, INC. ARE INSTRUMENTS OF SERVICE AND SHALL REMAIN THE PROPERTY OF BWC. BWC SHALL BE DEEMED THE AUTHOR AND SHALL RETAIN ALL COMMON LAW, STATUTORY AND OTHER RESERVED RIGHTS, INCLUDING THE COPYRIGHT HEREIN, IN ACCEPTING ANY DRAWINGS, REPORTS AND DATA ON ANY FORM OF ELECTRONIC MEDIA GENERATED AND FURNISHED BY BWC. THE CLIENT AGREES NOT TO REUSE THESE ELECTRONIC FILES, IN WHOLE OR IN PART, FOR ANY PURPOSE OTHER THAN FOR THIS PROJECT. THE CLIENT FURTHER AGREES NOT TO TRANSFER THESE ELECTRONIC FILES TO OTHERS WITHOUT THE PRIOR WRITTEN CONSENT OF BWC.

© COPYRIGHT 2019, Wesselink, Cook & Associates, Inc. 2019

**SITE ELECTRICAL PLAN**

WJW PROJECT NUMBER: 18836		SHEET NUMBER: E1.1
B.W.C. PROJECT NUMBER: 533-1902		
DSGN BY: GEH	DR. BY: JDH	CHK. BY: SDR

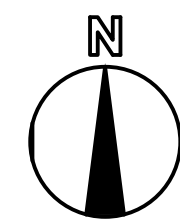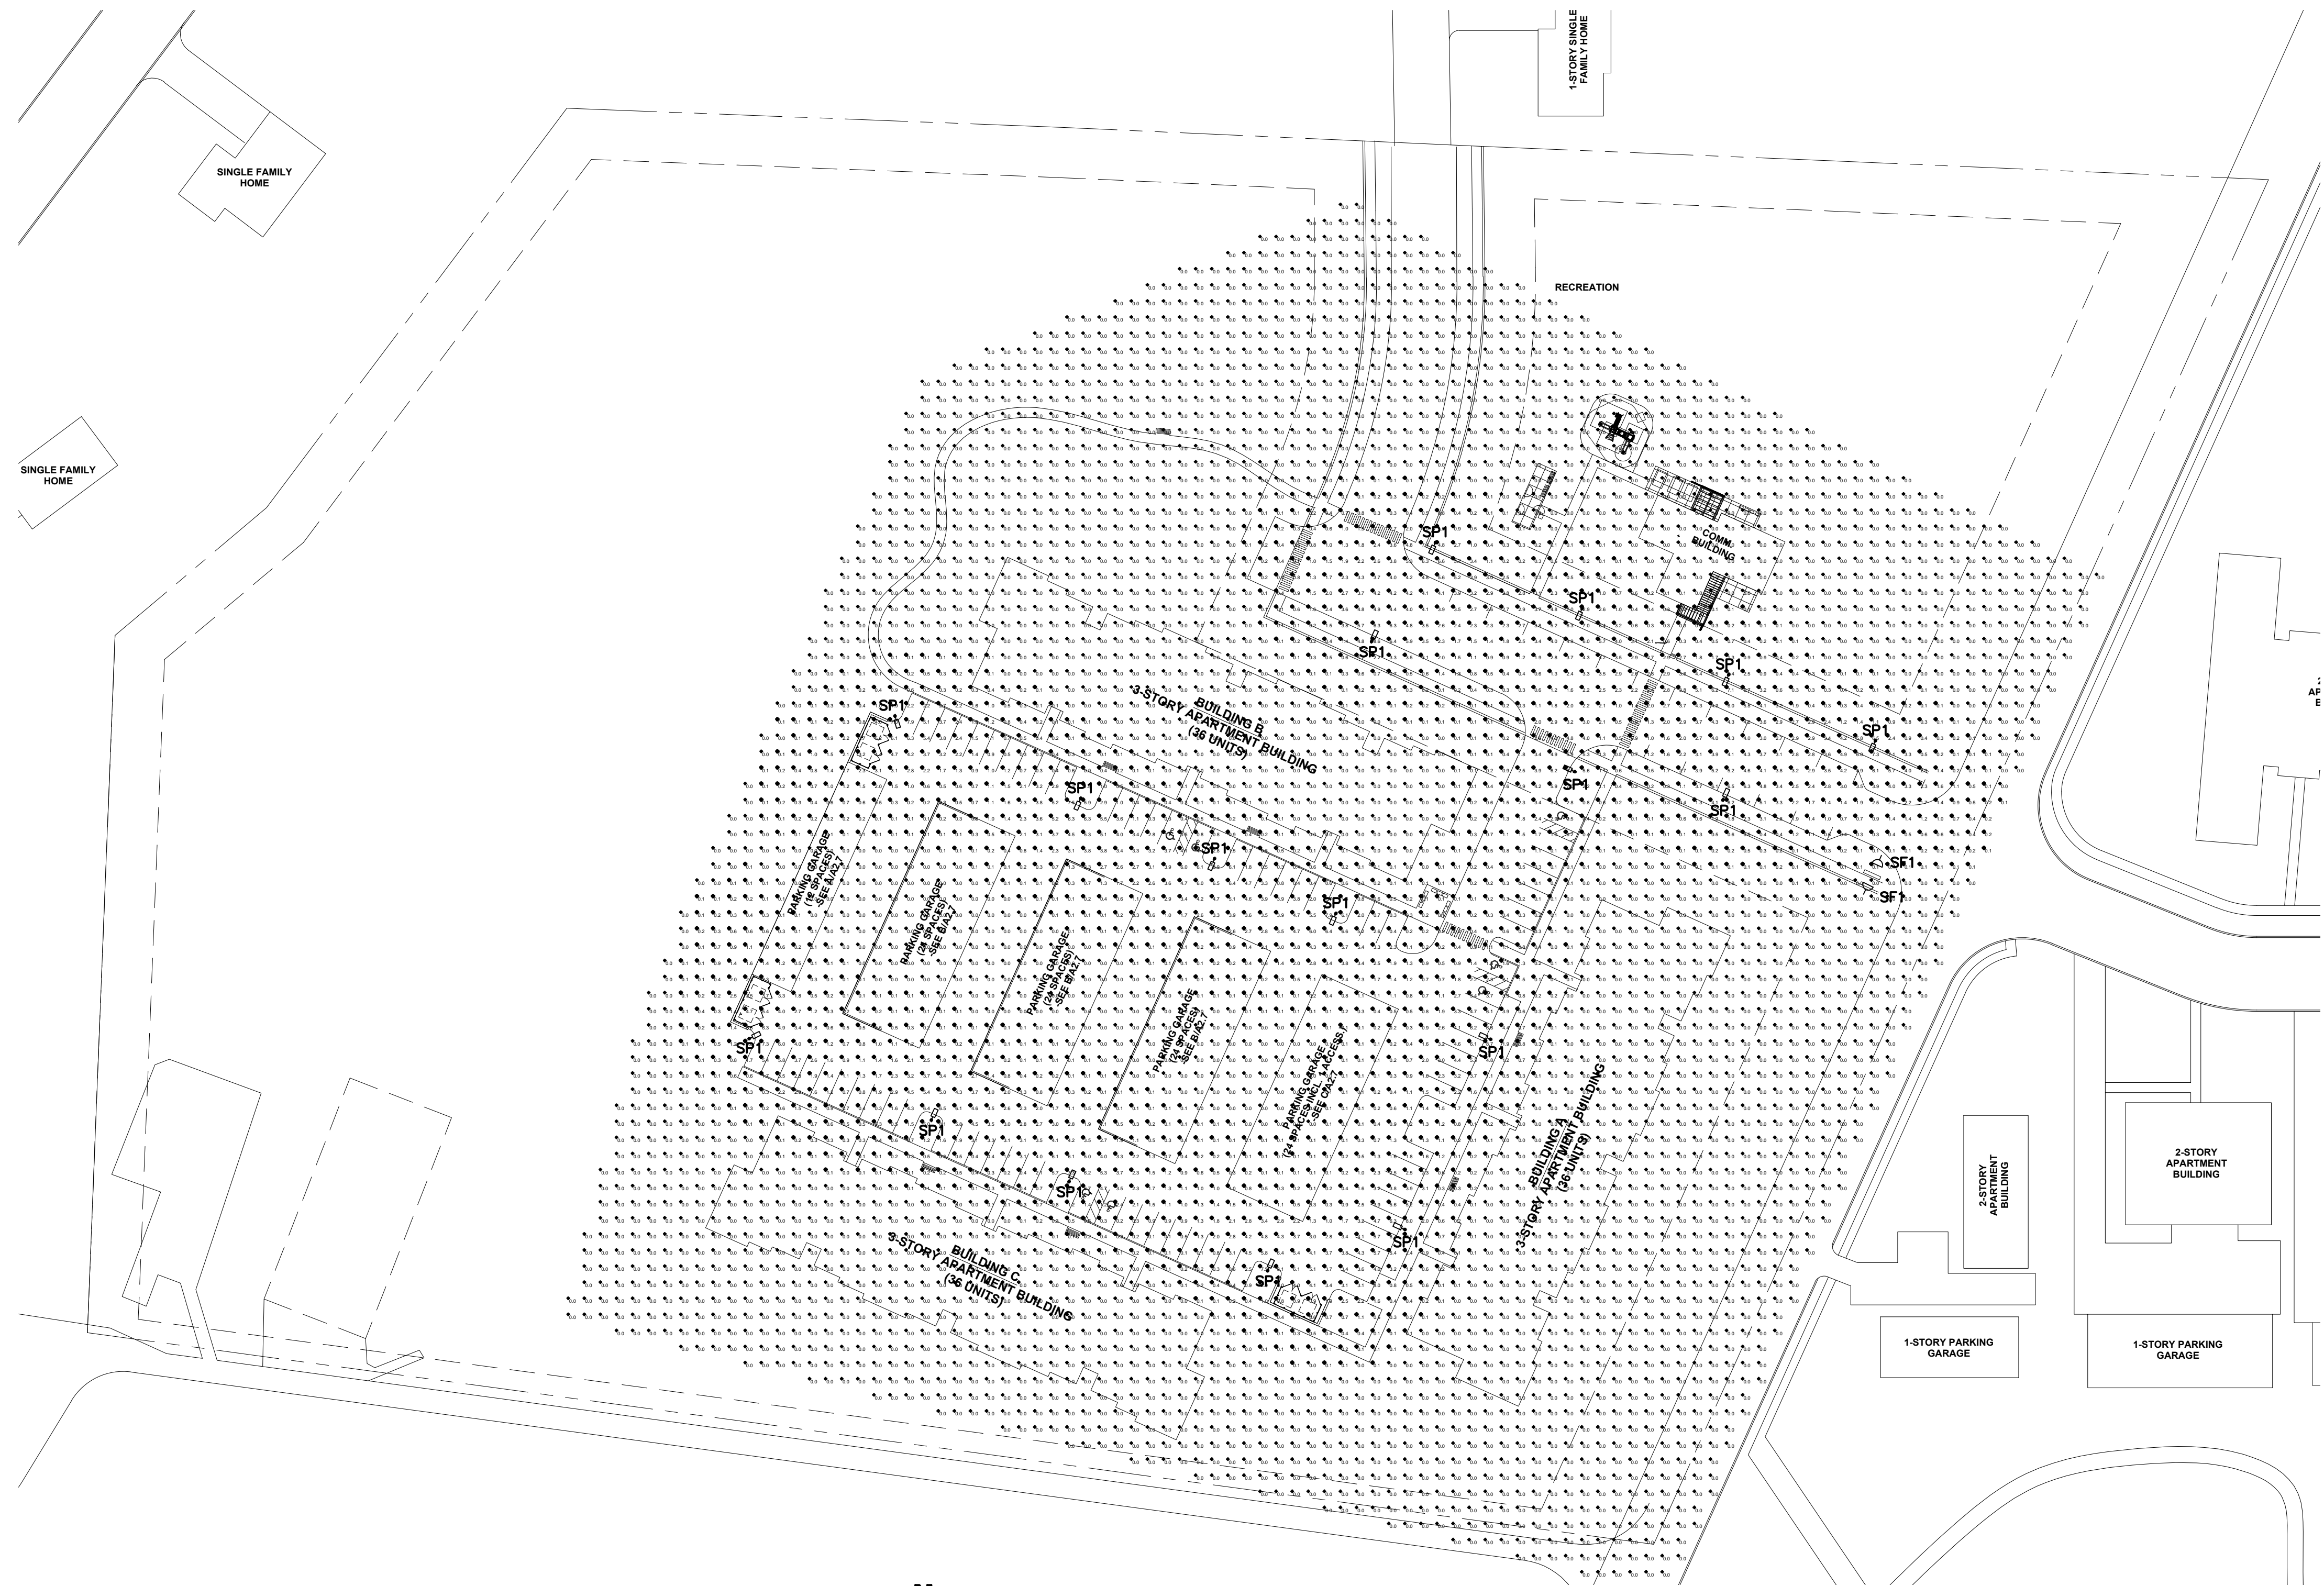

**SITE CALCULATION PLAN**  
SCALE 1"=50'-0"

# RED HAWK APARTMENTS

N. Parkview Drive & Blanche Drive  
Milton, WI 53563



**BLANK, WESSELINK, COOK & ASSOCIATES, INC.**

**ENGINEERS** • **CONSULTANTS**  
DESIGN FIRM LICENSE NO. 184.000894  
2623 EAST PERSHING ROAD DECATUR, IL 62524-2910 217-428-0973 FAX 217-428-8934

**WORN JERABEK WILTSE ARCHITECTS, P.C.**

401 West Superior St, Suite 400  
Chicago, IL 60654  
PH: 312.642.5587 FAX: 312.642.4189 www.wjwarchitecture.com

NO.	ISSUED FOR:	DATE
1	100% DESIGN DEVELOPMENT	8/12/19
3	ISSUED FOR PERMIT	9/09/19

**FOR BID/PERMIT**

ALL REPORTS, PLANS, SPECIFICATIONS, COMPUTER FILES, FIELD DATA, NOTES AND OTHER DOCUMENTS, INCLUDING THOSE IN ELECTRONIC FORM, PREPARED BY BWC, INC. ARE INSTRUMENTS OF SERVICE AND SHALL REMAIN THE PROPERTY OF BWC. BWC SHALL BE DEEMED THE AUTHOR AND SHALL RETAIN ALL COMMON LAW, STATUTORY AND OTHER RESERVED RIGHTS, INCLUDING THE COPYRIGHT HEREIN, IN ACCEPTING ANY DRAWINGS, REPORTS AND DATA ON ANY FORM OF ELECTRONIC MEDIA GENERATED AND FURNISHED BY BWC. THE CLIENT AGREES NOT TO REUSE THESE ELECTRONIC FILES, IN WHOLE OR IN PART, FOR ANY PURPOSE OTHER THAN FOR THIS PROJECT. THE CLIENT FURTHER AGREES NOT TO TRANSFER THESE ELECTRONIC FILES TO OTHERS WITHOUT THE PRIOR WRITTEN CONSENT OF BWC.

**SITE PHOTOMETRIC PLAN**

WJW PROJECT NUMBER: <b>18836</b>		SHEET NUMBER: <b>E1.2</b>
B.W.C. PROJECT NUMBER: <b>533-1902</b>		
DESIGN BY: GEN	DR. BY: JDH	CHK. BY: SDR

BUILDINGS – LUMINAIRE SCHEDULE					
ID	BASIS OF DESIGN		ELECTRICAL DATA		
	MANUFACTURER	MODEL NUMBER	LOAD (VA)	NUM.	TYPE
EF-2	?	?	34	-	?
EM1	LITHONIA	#ELM2-LED	2	2	LED
EX1	LITHONIA	#EDG-1-R-EL	3	1	LED
F1	LUMENART	#XBP-.3-12W-UNV WC-	12	1	LED
F10	LITHONIA	#LBL4W-6500LM-80CRI-30K-MIN1-ZT-MVOLT-EL14L-LSXRHL-PIR	50.1	1	LED
F11	LITHONIA	#WL4-40L-EZ1-LP830-NESPDT7-DIM50-EL14L	39.5	1	LED
F12	LEVITON	#R50-08827-CW4	11	1	LED
F2	LUMENART	#XBP-.2-12W-UNV WC-	12	1	LED
F3	LUMENART	#XBP-.1-12W-UNV WC-	12	1	LED
F4	EATON	#SMD4R-6-930-WH	10	1	LED
F5	BROWNLEE	#5174-25-BN-H21-35K-90R	21	1	LED
F6	TECH LIGHTING	#700WCOS-830-18-Y-Z-UNV-S	29.2	1	LED
F7	BARN LIGHT	#BLE-S-WHS12-100-G1-NA-NA-LED27	27	1	LED
F8	LITHONIA	#LBL4-30L-EZ1-LP830	26	1	LED
F9	LITHONIA	#OLWX1-LED-40K-MVOLT-PE	40	1	LED
FU7	WACLIGHTING	#WS-W52-BZ	21	1	LED
G1	LITHONIA	#FMLWL-48-8-30	42	1	LED
G2	LITHONIA	#LIL-LED-30K-MVOLT-PE-DBTDX	8.4	1	LED

UNIT – LUMINAIRE SCHEDULE					
ID	BASIS OF DESIGN		ELECTRICAL DATA		
	MANUFACTURER	MODEL NUMBER	LOAD (VA)	NUM.	TYPE
EF	?	?	34	-	?
FU1	HOME DECORATORS COLLECTION	#52-WWDIV	57	1	LED
FU2	LITHONIA	#FMLRL14-30	24	1	LED
FU3	LITHONIA	#FMVCCL-24-MVOLT-30-90CRI-BN	18	1	LED
FU4	EATON	#SMD4R-6-930-WH	10	1	LED
FU5	LEVITON	#C20-09852-000	10	1	LED
FU6	LITHONIA	#UCEL-24IN-30-90CRI-SWR-WH	10	1	LED
FU7	WACLIGHTING	#WS-W52-BZ	21	1	LED

SITE – LUMINAIRE SCHEDULE					
ID	BASIS OF DESIGN		ELECTRICAL DATA		
	MANUFACTURER	MODEL NUMBER	LOAD (VA)	NUM.	TYPE
SP1	LITHONIA	#DSX1-LED-30C-530-30K-T4M-MVOLT-HS-PE	52	1	LED

# RED HAWK APARTMENTS

N. Parkview Drive & Blanche Drive  
Milton, WI 53563



**BLANK, WESSELINK, COOK & ASSOCIATES, INC.**

**ENGINEERS** • **CONSULTANTS**  
DESIGN FIRM LICENSE NO. 184.000894  
2623 EAST PERSHING ROAD 217-428-0973  
DECATUR, IL 62524-2910 FAX 217-428-8934

**WORN JERABEK WILTSE ARCHITECTS, P.C.**

401 West Superior St, Suite 400  
Chicago, IL 60654  
PH: 312.642.5587 FAX: 312.642.4189 www.wjwarchitecture.com

NO.	ISSUED FOR	DATE
1	100% DESIGN DEVELOPMENT	8/12/19
3	ISSUED FOR PERMIT	9/09/19

**FOR BID/PERMIT**

ALL REPORTS, PLANS, SPECIFICATIONS, COMPUTER FILES, FIELD DATA, NOTES AND OTHER DOCUMENTS, INCLUDING THOSE IN ELECTRONIC FORM, PREPARED BY BWC, INC. ARE INSTRUMENTS OF SERVICE AND SHALL REMAIN THE PROPERTY OF BWC. BWC SHALL BE DEEMED THE AUTHOR AND SHALL RETAIN ALL COMMON LAW, STATUTORY AND OTHER RESERVED RIGHTS, INCLUDING THE COPYRIGHT HEREIN, IN ACCEPTING ANY DRAWINGS, REPORTS AND DATA ON ANY FORM OF ELECTRONIC MEDIA GENERATED AND FURNISHED BY BWC. THE CLIENT AGREES NOT TO REUSE THESE ELECTRONIC FILES, IN WHOLE OR IN PART, FOR ANY PURPOSE OTHER THAN FOR THIS PROJECT. THE CLIENT FURTHER AGREES NOT TO TRANSFER THESE ELECTRONIC FILES TO OTHERS WITHOUT THE PRIOR WRITTEN CONSENT OF BWC.

**LIGHT FIXTURE SCHEDULE**

WJW PROJECT NUMBER:

18836

B.W.C. PROJECT NUMBER:

533-1902

DSGN BY: DR. BY: CK. BY:

GEN JDH SDR

SHEET NUMBER:

**E10.1**