

PROJECT INFORMATION

PROPOSED RC HUB TRUCKING FACILITY FOR:
CLASEN QUALITY CHOCOLATE
 MILTON PLANT • MILTON, WI 53563

PROFESSIONAL SEAL

PRELIMINARY DATES

APR. 8, 2022
APR. 29, 2022
JUNE 15, 2022
JUNE 23, 2022
JUNE 28, 2022


NOT FOR CONSTRUCTION

JOB NUMBER
2220680



SHEET NUMBER
A1.1AB

SYMBOLS LEGEND

(Symbol)	SEE SHEET A4 SHEETS FOR WALL TYPES
(Symbol)	SEE SHEET A4 SHEETS FOR CURB DETAILS
(Symbol)	EXIT SIGNAGE
(Symbol)	FIRE EXTINGUISHER - SEE AS SHEETS
(Symbol)	FIRE EXTINGUISHER w/ CABINET - SEE AS SHEETS
(Symbol)	DRINKING FOUNTAIN - SEE PLUMBING PLANS
(Symbol)	HAND WASH - SEE PLUMBING PLANS
(Symbol)	HOSE STATION - SEE PLUMBING PLANS
(Symbol)	HOSE STATION - SEE PLUMBING PLANS
(Symbol)	HOSE STATION - SEE PLUMBING PLANS
(Symbol)	HOSE STATION - SEE PLUMBING PLANS
(Symbol)	GUARD POST/GOAL POST DESIGNATION - SEE SHEET A6 SHEETS
(Symbol)	STUD WALL
(Symbol)	C.M.I. WALL
(Symbol)	(1) HOUR FIRE RATED
(Symbol)	(2) HOUR FIRE RATED
(Symbol)	(3) HOUR FIRE RATED
(Symbol)	(4) HOUR FIRE RATED
(Symbol)	SEE PLAN FOR ALL WALL WIDTHS
(Symbol)	NEW DOOR

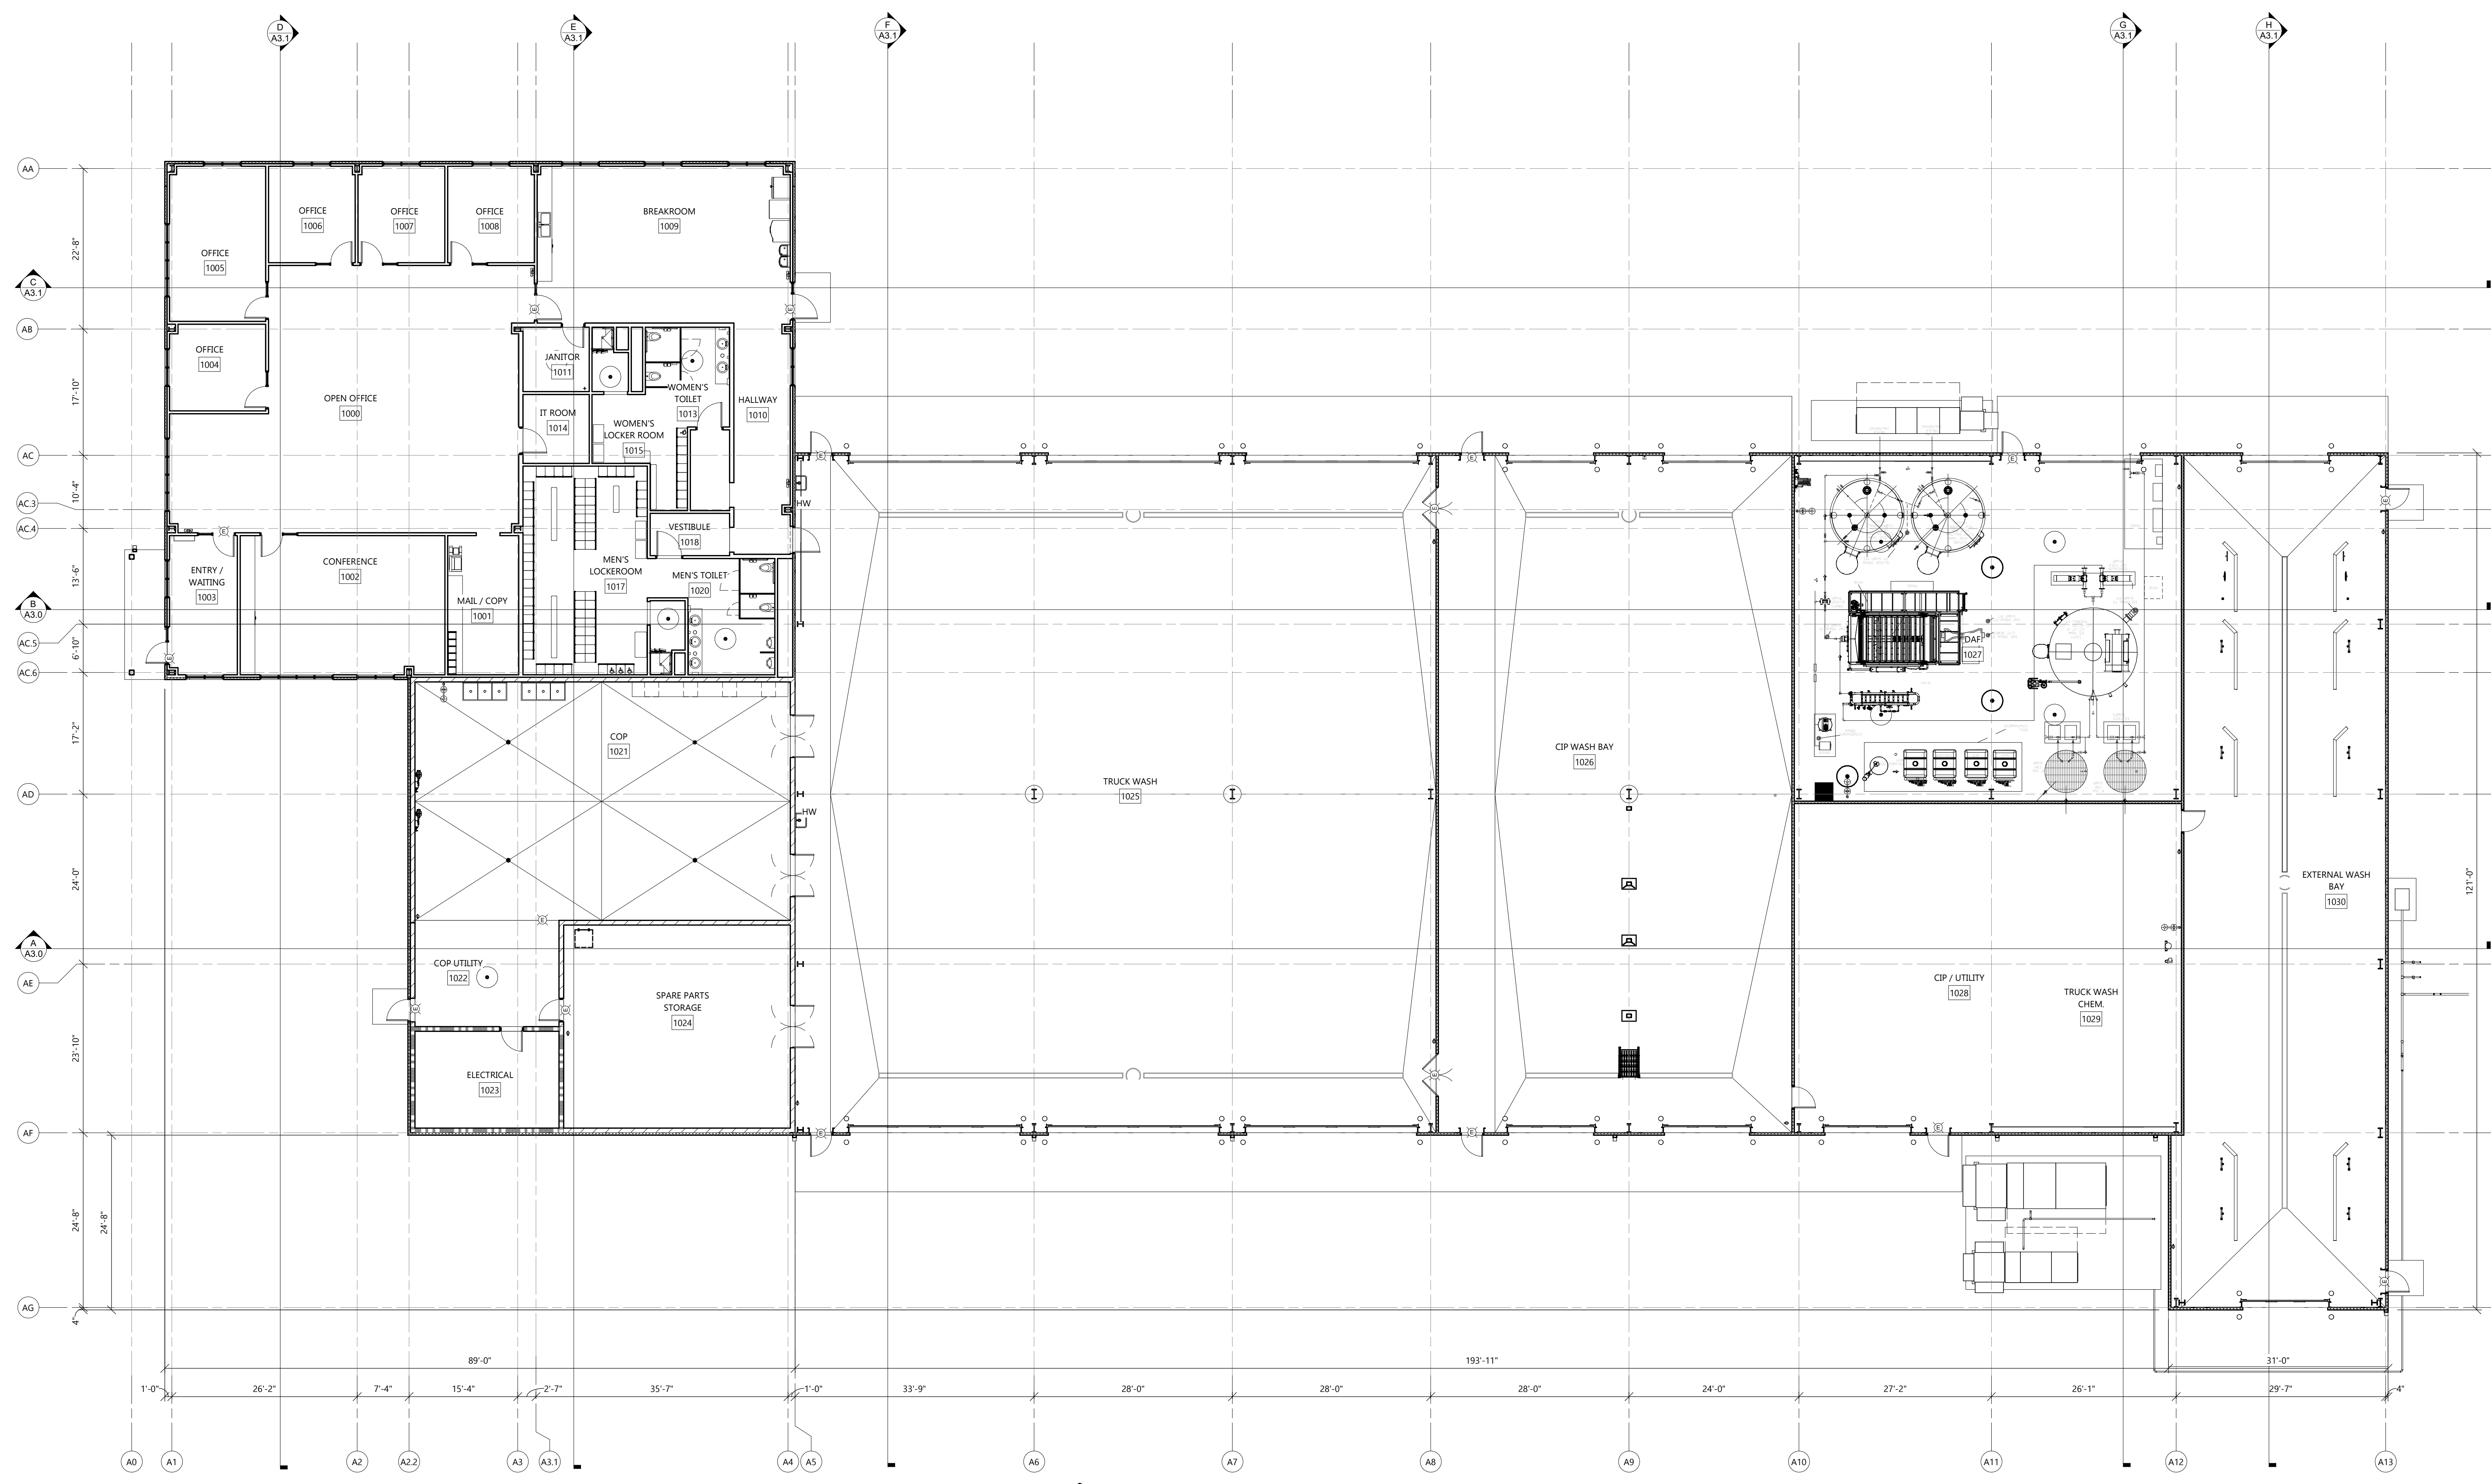

FIRST FLOOR PLAN - AREA 'A' & 'B'
 NORTH SCALE: 3/32" = 1'-0"
 10' 0' 10' 20'

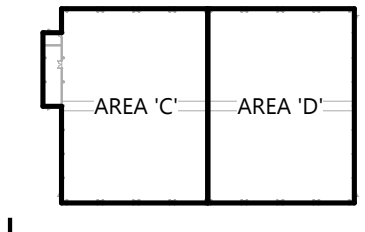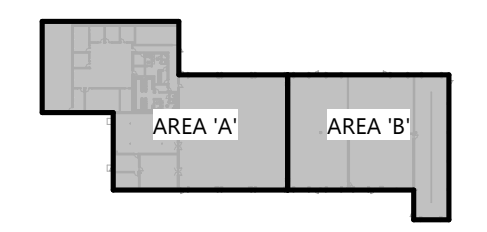

KEY PLAN
 ARCHITECTURAL FIRST FLOOR PLAN - AREA 'A' & 'B'