



**SYMBOLS LEGEND**

- SEE SHEET A4 SHEETS FOR WALL TYPES
- SEE SHEET A4 SHEETS FOR CURB DETAILS
- EXIT SIGNAGE
- FIRE EXTINGUISHER -SEE A5 SHEETS
- FIRE EXTINGUISHER w/ CABINET -SEE A5 SHEETS
- DRINKING FOUNTAIN -SEE PLUMBING PLANS
- HAND WASH -SEE PLUMBING PLANS
- HOSE STATION -SEE PLUMBING PLANS
- HOSE STATION -SEE PLUMBING PLANS
- HOSE STATION -SEE PLUMBING PLANS
- GUARD POST/GOAL POST DESIGNATION -SEE SHEET A6 SHEETS
- STUD WALL
- C.M.U. WALL
- (1) HOUR FIRE RATED
- (2) HOUR FIRE RATED
- (3) HOUR FIRE RATED
- (4) HOUR FIRE RATED
- SEE PLAN FOR ALL WALL WIDTHS
- NEW DOOR

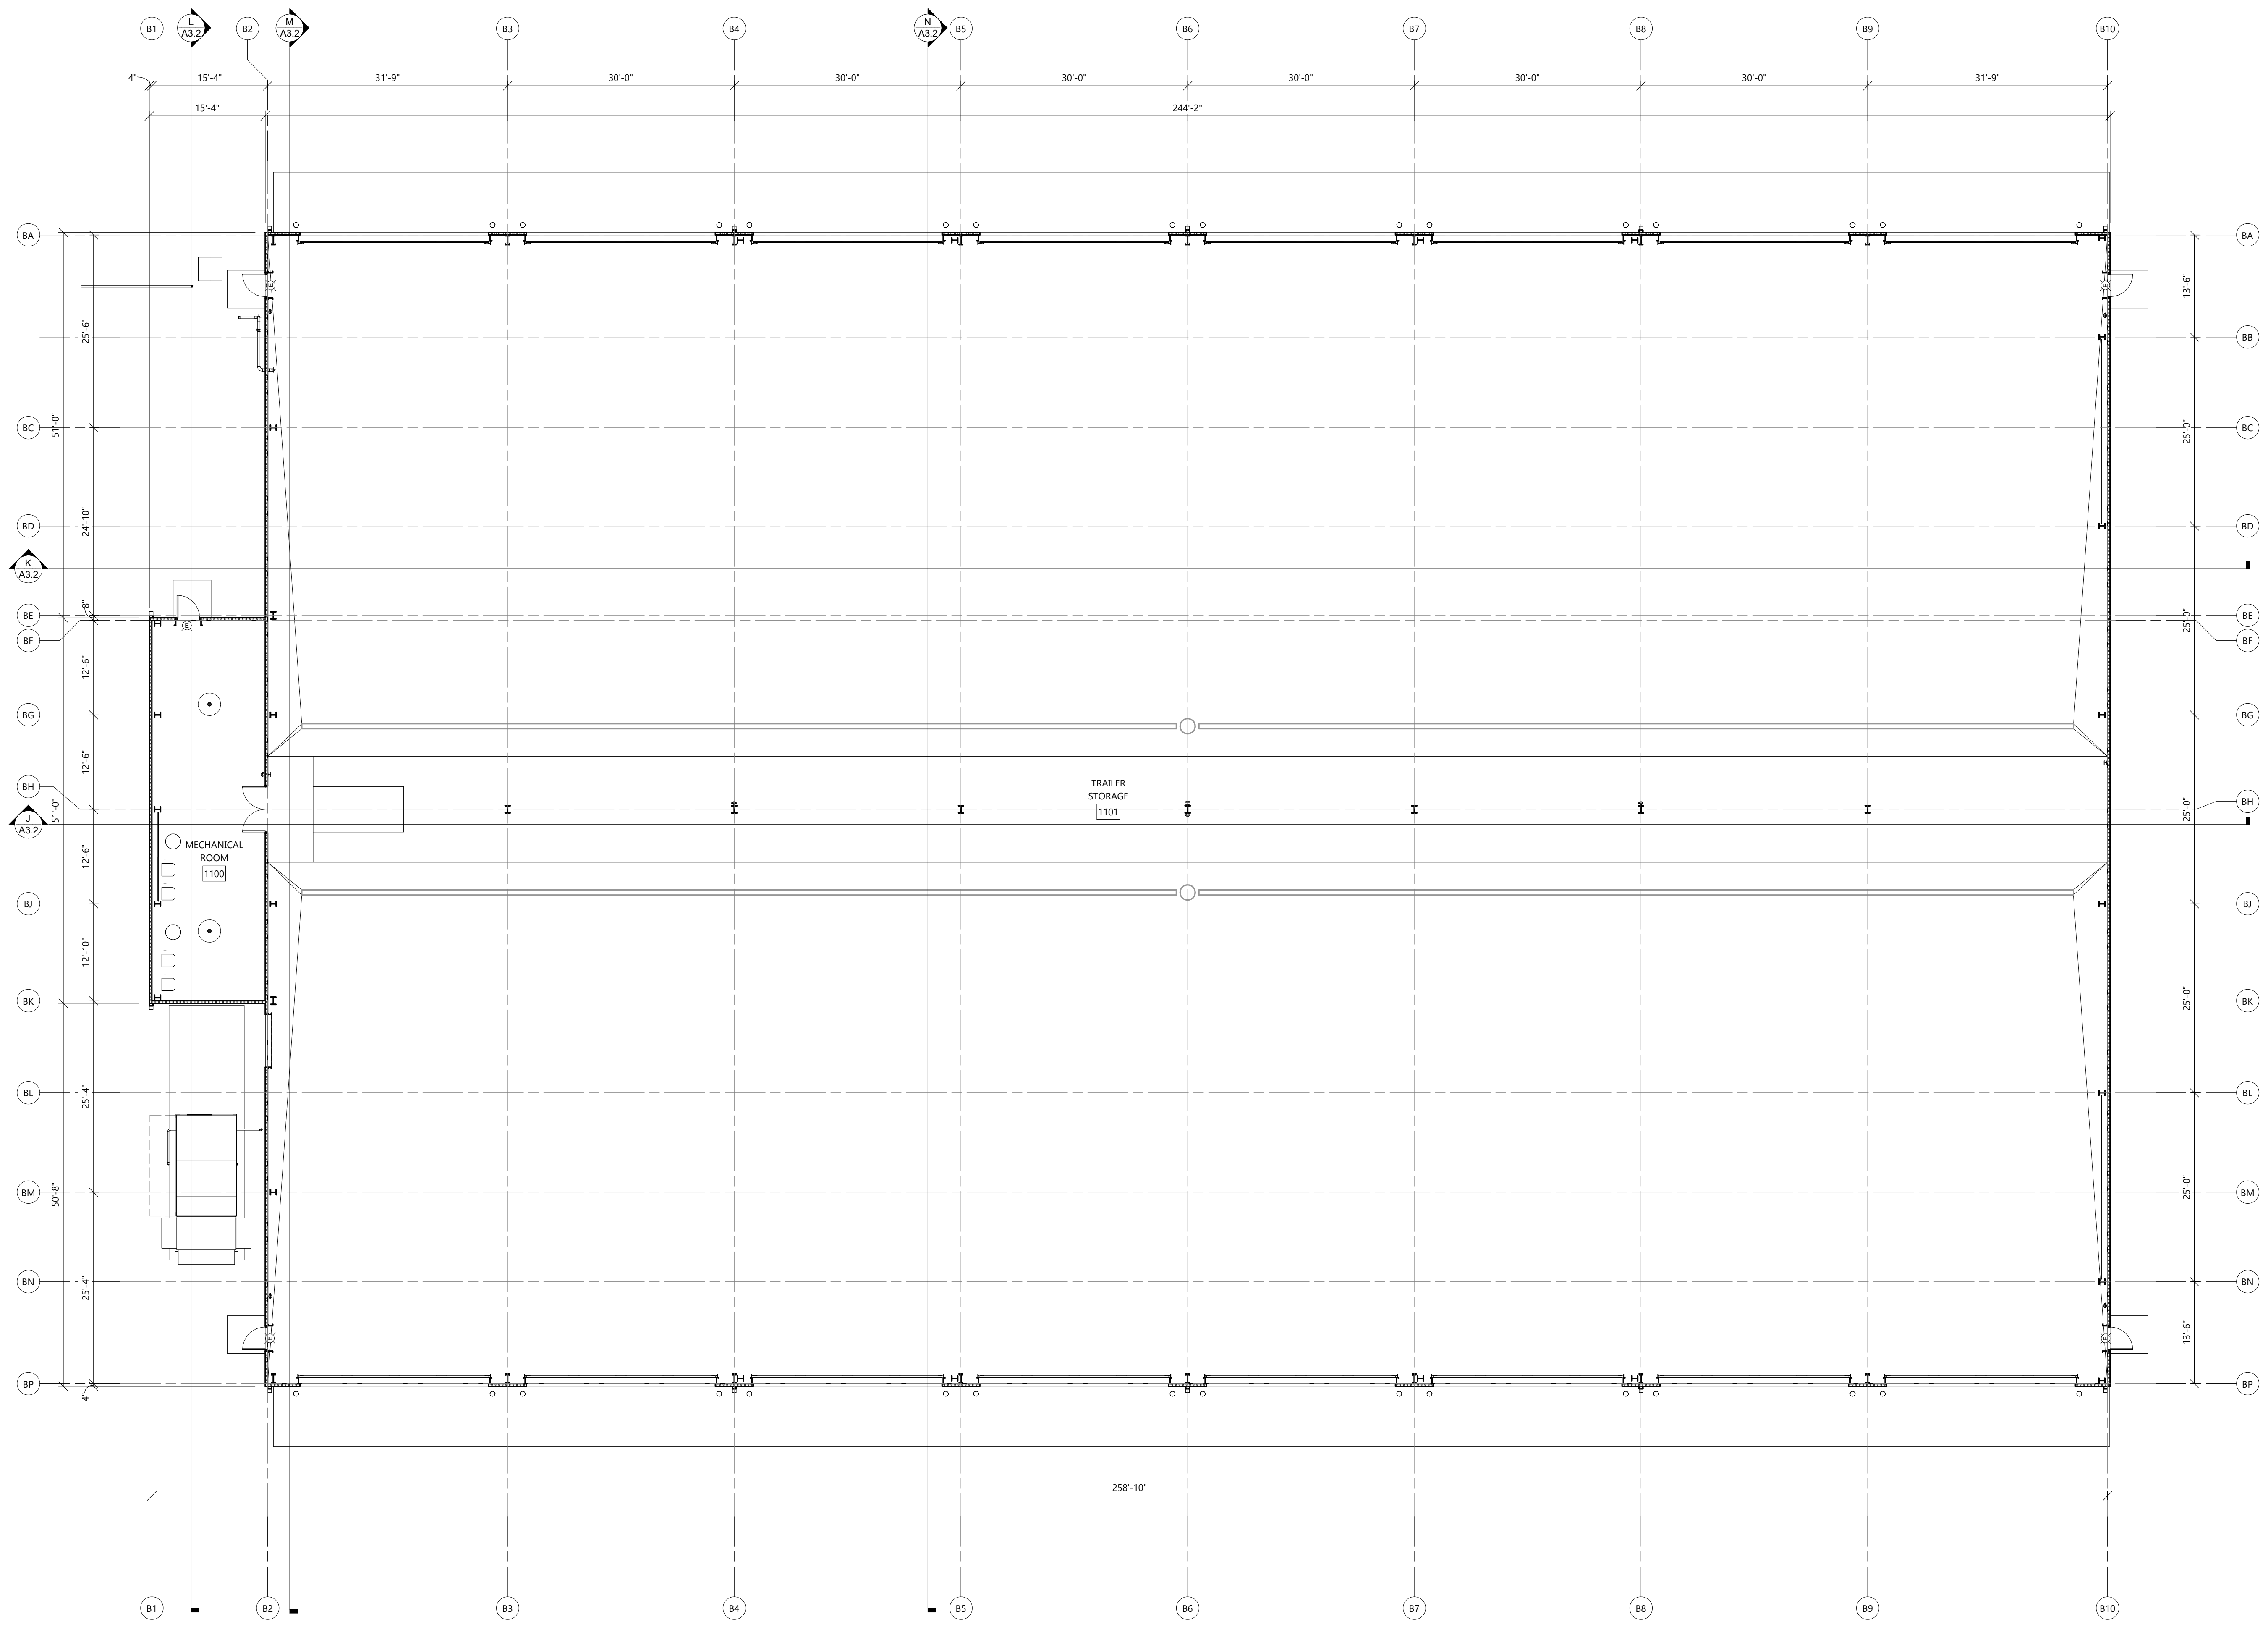

**FIRST FLOOR PLAN - AREA'S 'C' & 'D'**  
 SCALE: 3/32" = 1'-0"  
 NORTH

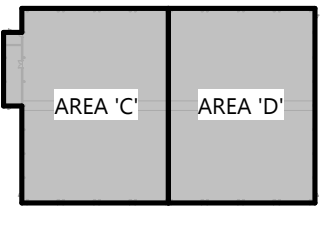

**KEY PLAN**  
 ARCHITECTURAL FIRST FLOOR PLAN - AREA 'C' & 'D'

**EXCEL**  
 ARCHITECTS • ENGINEERS • SURVEYORS  
**Always a Better Plan**  
 100 Camelot Drive  
 Fond Du Lac, WI 54935  
 Phone: (920) 926-9800  
 www.EXCELENGINEER.com

**COLLABORATION**  
 SINCE 1922  
**MAAS BROTHERS**  
 CONSTRUCTION  
 CO., INC.

P.O. Box 108  
 410 Water Tower Ct.  
 Watertown, WI 53094-0108  
 Phone: (920) 251-1682  
 Fax: (920) 261-3521

**PROJECT INFORMATION**

PROPOSED RC HUB TRUCKING FACILITY FOR:  
**CLASEN QUALITY CHOCOLATE**  
 MILTON PLANT • MILTON, WI 53563

PROFESSIONAL SEAL

**PRELIMINARY DATES**

APR. 8, 2022
APR. 29, 2022
JUNE 15, 2022
JUNE 23, 2022
JUNE 28, 2022

**NOT FOR CONSTRUCTION**

**JOB NUMBER**  
 2220680

**SHEET NUMBER**  
**A1.1CD**

C:\Users\jwagner\Documents\2220680\A1.1CD\A1.1CD.dwg, 11/22/2022, 10:11:00 AM, jwagner